
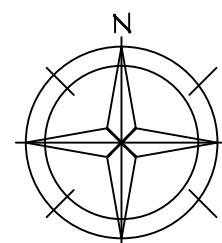
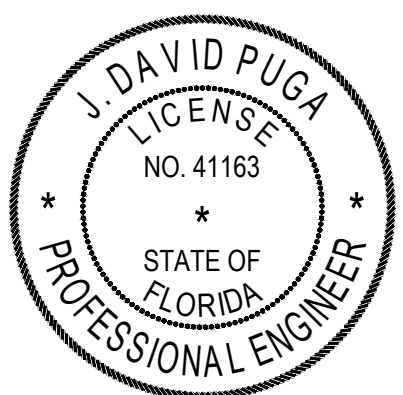


Symbol	Qty	Label	Arrangement	Total Lamp Lumens	LLF	[MANUFAC]	Description	Lum. Watts	Total Watts
[Symbol]	11	SA	SINGLE	N.A.	0.850	U.S. ARCHITECTURAL LIGHTING	VLL-LED-PLED-80LED-IV-FT-1050mA-NW-NS-PLED (POLE MTD AT 30')	280.8	3088.8
[Symbol]	5	SB	SINGLE	N.A.	0.850	U.S. ARCHITECTURAL LIGHTING	VLL-LED-PLED-80LED-11-1050mA-NW-NS-PLED (POLE MTD AT 30')	277.6	1388
[Symbol]	4	SC	BACK-BACK	N.A.	0.850	U.S. ARCHITECTURAL LIGHTING	VLL-LED-PLED-80LED-V9Q-N-1050mA-NW (POLE MTD AT 30')	280.8	2246.4
[Symbol]	1	SD	SINGLE	N.A.	0.850	U.S. ARCHITECTURAL LIGHTING	VLL-LED-PLED-80LED-IV-FT-1050mA-NW (POLE MTD AT 30')	280.3	280.3
[Symbol]	1	SE	SINGLE	N.A.	0.850	U.S. ARCHITECTURAL LIGHTING	VLL-LED-PLED-80LED-IV-1050mA-NW-NS-PLED (POLE MTD AT 30')	277.6	277.6
[Symbol]	2	SF	SINGLE	N.A.	0.850	U.S. ARCHITECTURAL LIGHTING	VLL-LED-PLED-80LED-111-N-1050mA-NW-NS-PLED (POLE MTD AT 30')	277.4	554.8
[Symbol]	18	SW	SINGLE	N.A.	0.850	U.S. ARCHITECTURAL LIGHTING	RER-WM2-PLED-IV-FT-40LED-1050mA-NW (WALL MTD AT 26')	128.2	2307.6

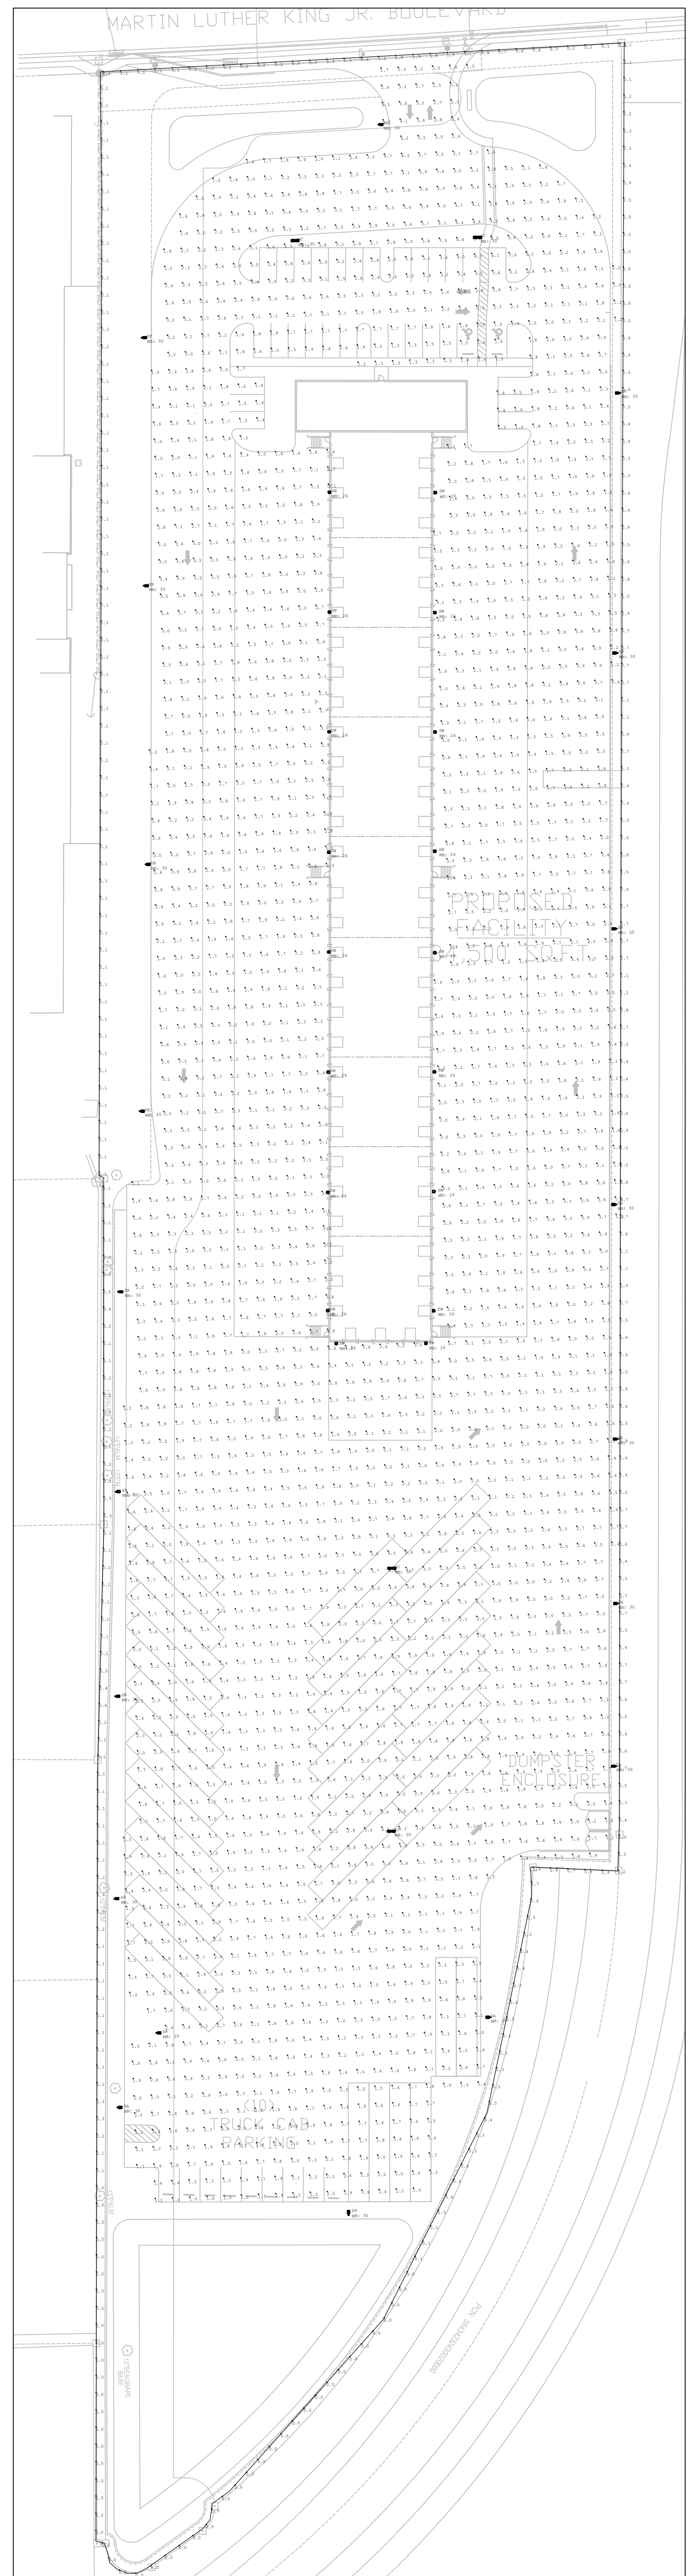

PHOTOMETRIC SITE PLAN
SCALE: 1" = 30'-0"

Puga and Associates, Inc.
Engineers/Consultants
EB 0005813
7700 N Kendall Drive, Suite 808
Miami, Florida 33156
(305) 681-7700

©CORNERSTONE ARCHITECTS LTD. 2021

PROPOSED FACILITY

1463-1481 MARTIN LUTHER KING JR. BOULEVARD, RIVIERA BEACH, FLORIDA

DECEMBER 9, 2021

#21318

