

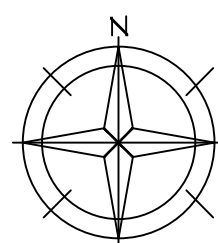
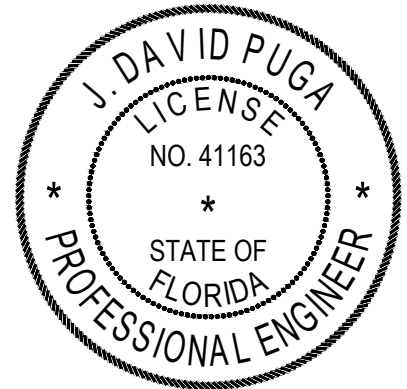


Label	Quantity	Units	Any	Max	Min	Height	Mount
EXPANDED SPALL LIGHTING	ILLUMINANCE	FC	0.11	5.0	0.0	N.A.	N.A.
POLE LIGHTING	ILLUMINANCE	FC	2.03	5.0	0.0	0.00	
POLE LIGHTING	ILLUMINANCE	FC	0.40	5.0	0.0	N.A.	N.A.

Fixture Schedule	Label	Arrangement	Total Lamp Output	W.P.	(MINIMUM)	Description	Low Rate	High Rate
1	08	SINGLE	0.450	0.0	0.0	ARCHITECTURAL LIGHTING	205.8	1089.3
2	08	SINGLE	0.450	0.0	0.0	ARCHITECTURAL LIGHTING	217.6	1388
3	08	BACK-TO-BACK	0.450	0.0	0.0	ARCHITECTURAL LIGHTING	260.8	2246.4
4	08	SINGLE	0.450	0.0	0.0	ARCHITECTURAL LIGHTING	280.2	280.2
5	08	SINGLE	0.450	0.0	0.0	ARCHITECTURAL LIGHTING	275.8	275.8
6	08	SINGLE	0.450	0.0	0.0	ARCHITECTURAL LIGHTING	217.4	214.8
7	08	SINGLE	0.450	0.0	0.0	ARCHITECTURAL LIGHTING	128.2	207.6

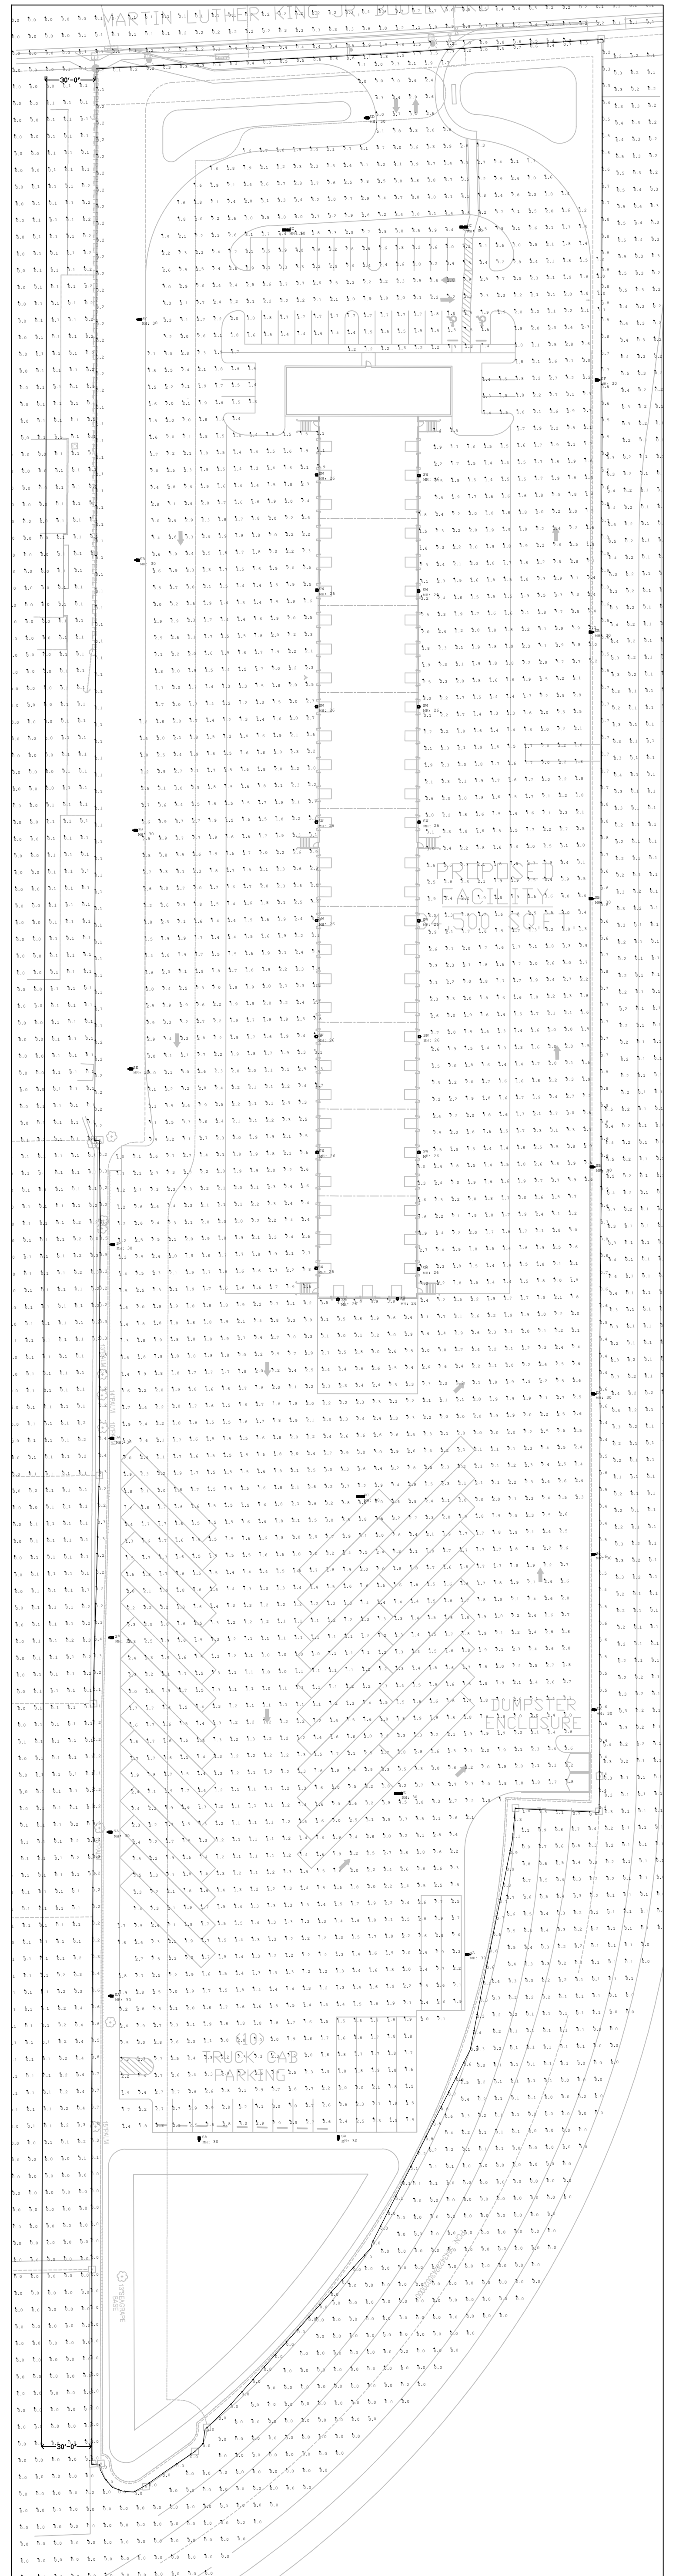

PHOTOMETRIC SITE PLAN  
SCALE: 1" = 30'-0"

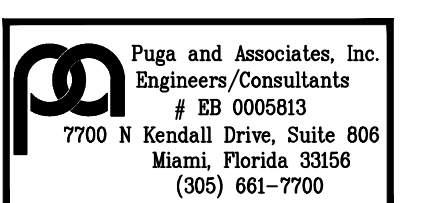

©CORNERSTONE ARCHITECTS LTD. 2021

PROPOSED FACILITY  
1463-1481 MARTIN LUTHER KING JR. BOULEVARD, RIVIERA BEACH, FLORIDA

02/17/2022 DRC Comments

DECEMBER 9, 2021

#21318

